



29/6/2003
DRAINAGE PLAN
DORNOCH HERITAGE CENTRE

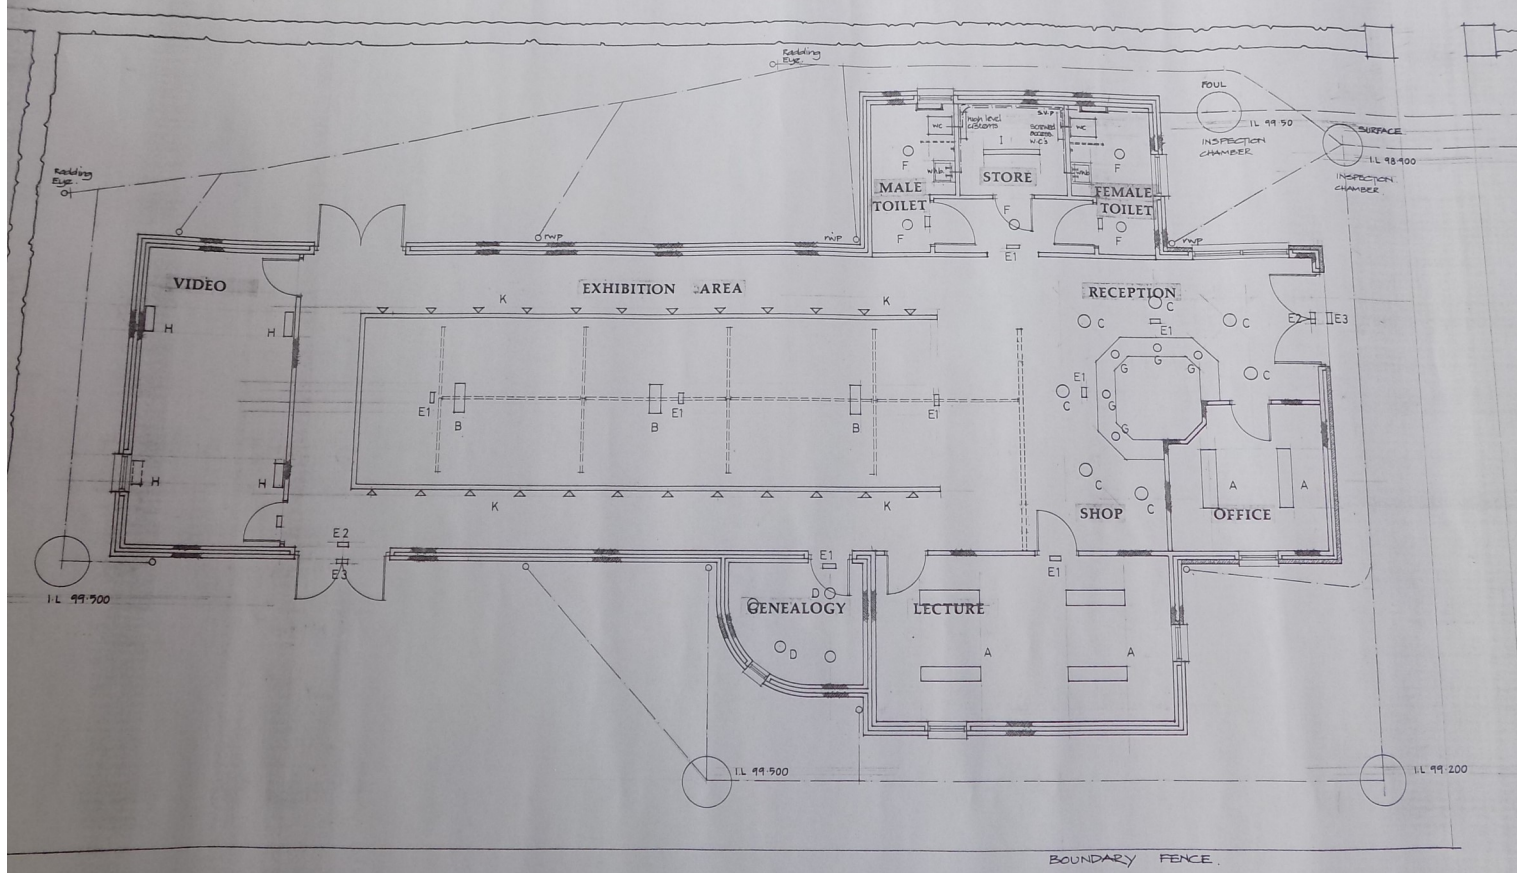

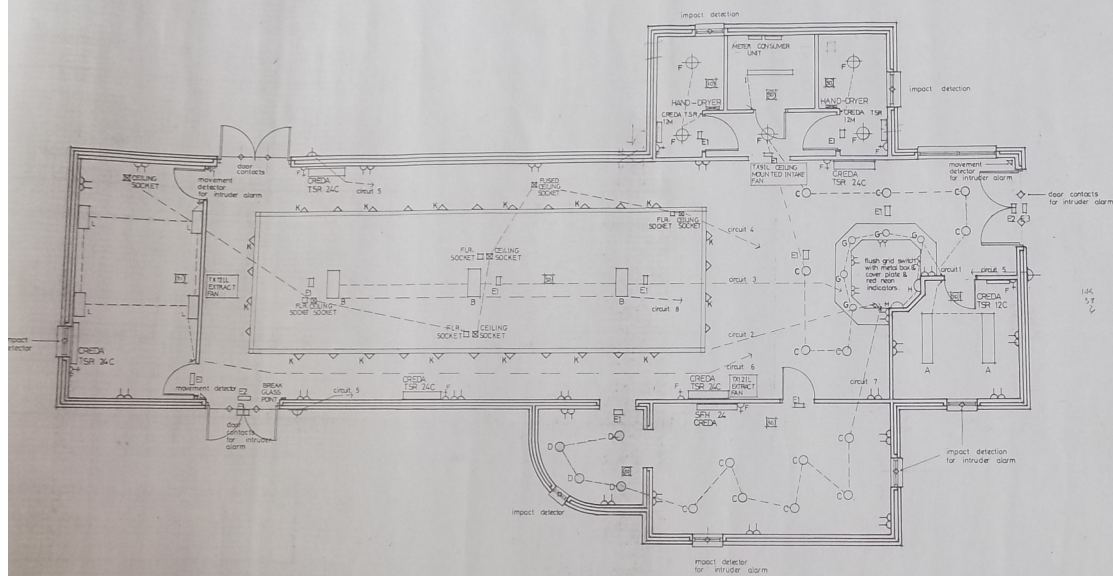

- A QUATTRO C LINE
- B CEL9025 SUSPENDED UP LIGHT
- C CDH118/5B RECESSED CHALK
- D CDH513/5B RECESSED CHALK
- F 2DD5 C2W DISCET
- G TRR 50BR DOWNLIGHT
- H CORACLE WALL MOUNTED UP LIGHT
- I PP5B POPULAR PACK
- K TMM T550 W CAMERA SPOT
- L ATURA ULFZZ25
- E1 ECB CRUSADER BULKHEAD
- E2 EXT PICTOGRAM
- E3 EFV3 BULKHEAD
- D- WALL SOCKET OUTLET
- FLOOR FLOOR SOCKET OUTLET
- CEILING CEILING SOCKET OUTLET
- J5B J5B FX041 CEILING MOUNTED SD
- AIRSTREAM AIRSTREAM 2000 HAND-DRYER
- 3300S 3300S EXTERNAL LIGHT



GRAEME R. McLAUGHLIN
 B.Sc. Arch. Dip. Arch. A.R.I.A.S.


DIRECTOR OF TECHNICAL SERVICES AND HOUSING
THE MEADOWS
DORNOCH

tel. 0882 81901
 fax. 0882 81918

PROJECT
 DORNOCH HERITAGE CENTRE

DRAWING
 ELECTRICAL LAYOUT

DATE APRIL 96	DRAWN
SCALE 1:50	NUMBER 306/DCP/09

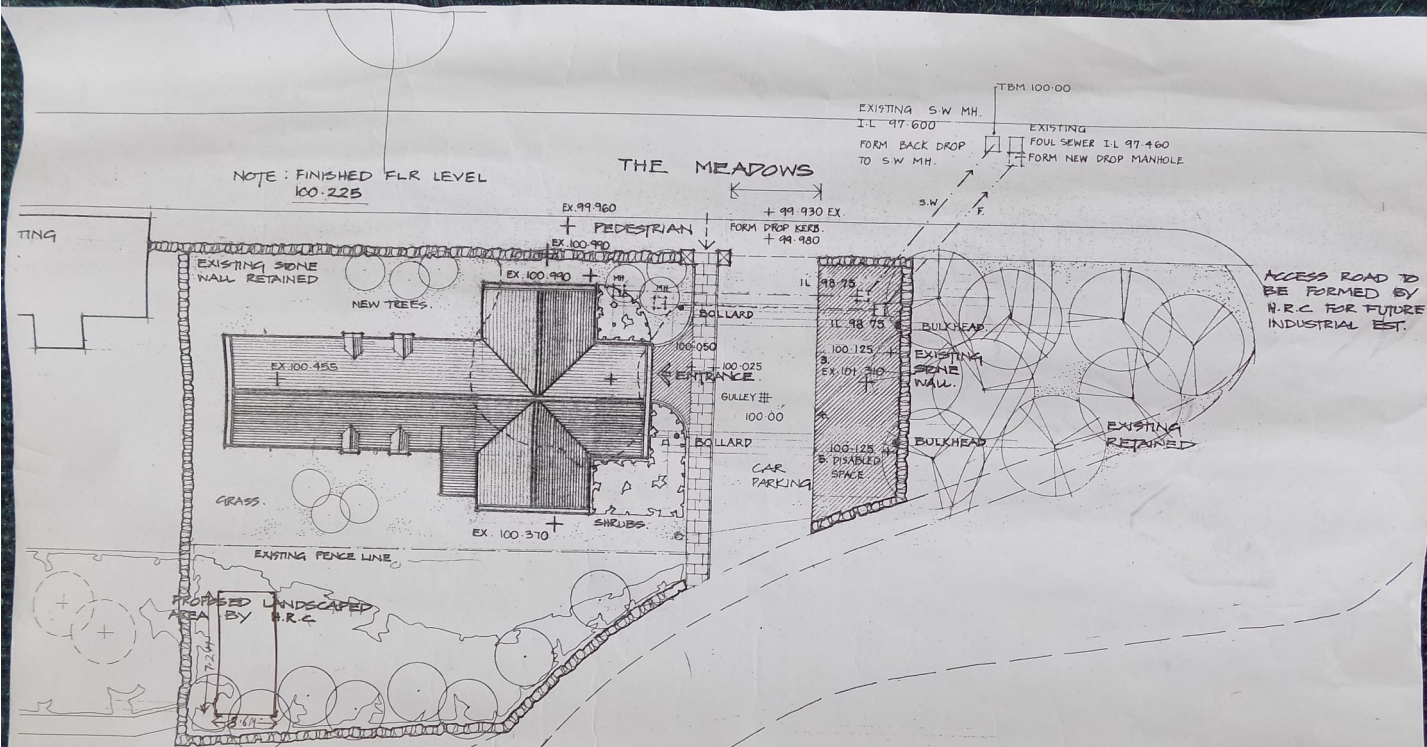

ACCESS ROAD TO BE FORMED BY N.R.C. FOR FUTURE INDUSTRIAL EST.

STORAGE SHED
 7.2M x 3.6M
 HEIGHT - WALLS 2M
~~APEX~~ APEX 2.5M
 WALLS - T/G WEATHERBOARD
 FLOOR - WOOD ON AERIEZE-BLOCK DWARF WALLS
 ROOF - BOX PROFILE METAL
 PAINT - DARK GREEN

SCALE 1:200